

GMS, INC.
CONSULTING ENGINEERS
611 NORTH WEBER, SUITE 300
COLORADO SPRINGS, COLORADO 80903-1074

TELEPHONE (719) 475-2935
TELEFAX (719) 475-2938

EDWARD D. MEYER, P.E.
ROGER J. SAMS, P.E.
GREGORY R. WORDEN, P.E.
THOMAS A. McCLERNAN, P.E.

KEN L. WHITE, P.L.S.
DAVID R. FRISCH, P.L.S.
MARK A. MORTON, P.E.
JASON D. MEYER, P.E.

ENGINEER'S SUPPLEMENTAL INSTRUCTIONS NO. TWENTY-EIGHT (28)
(Via Posting to FTP Site and Electronic Mail)

TO: Wes Weaver
John Jacob
Jeff Burst
Weaver Construction Management, Inc.

DATE: September 19, 2013

FROM: Mark A. Morton, P.E.
Roger J. Sams, P.E.
GMS, Inc.

RE: Harold D. Thompson Regional Water Reclamation Facility (HDTRWRF)-Phase 1
ENGINEER'S SUPPLEMENTAL INSTRUCTIONS TWENTY-EIGHT (ESI-28)


This ESI-028 provides information on work required in the UV disinfection channels to facilitate transfer of water between the two channels. The Drawings attached to this ESI-028 provide the installation details and construction requirements of the work. Refer to the list of attachments at the end of this ESI-028 for an itemization of those Drawings and Details.

If you should have any questions or desire additional information, please contact our office at your earliest convenience.

Attachments: Partial view of Disinfection Equipment and Piping Plan A/PD-11
Section B/PD-11: Channel Section


ec: Lower Fountain Metropolitan Sewage Disposal District
Fountain Sanitation District
Colorado Centre Metropolitan District

cc: Jerry Miller, GMS, Inc.
David R. Frisch, P.L.S., GMS, Inc.

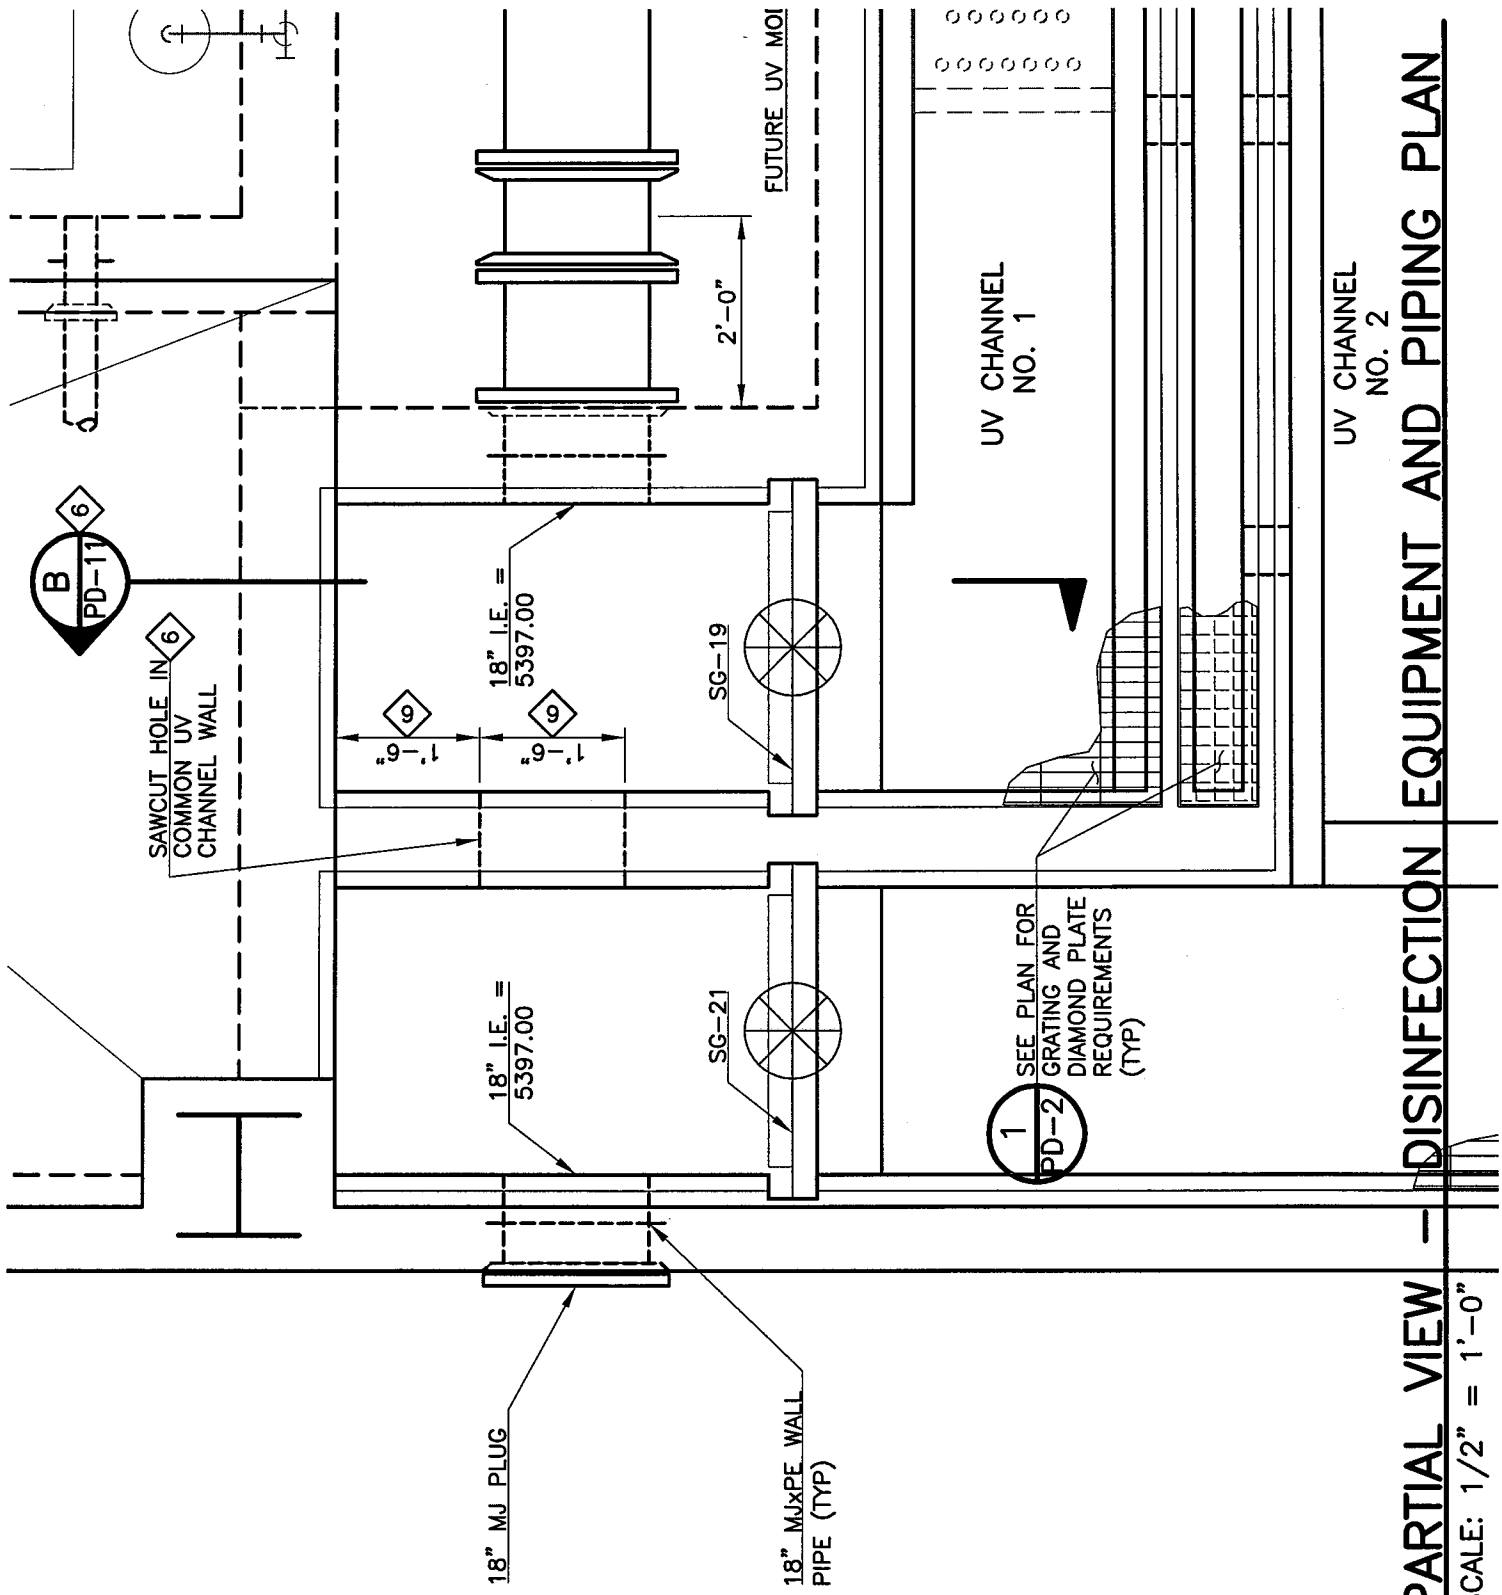

A PARTIAL VIEW — DISINFECTION EQUIPMENT AND PIPING PLAN

SCALE: 1/2" = 1'-0"

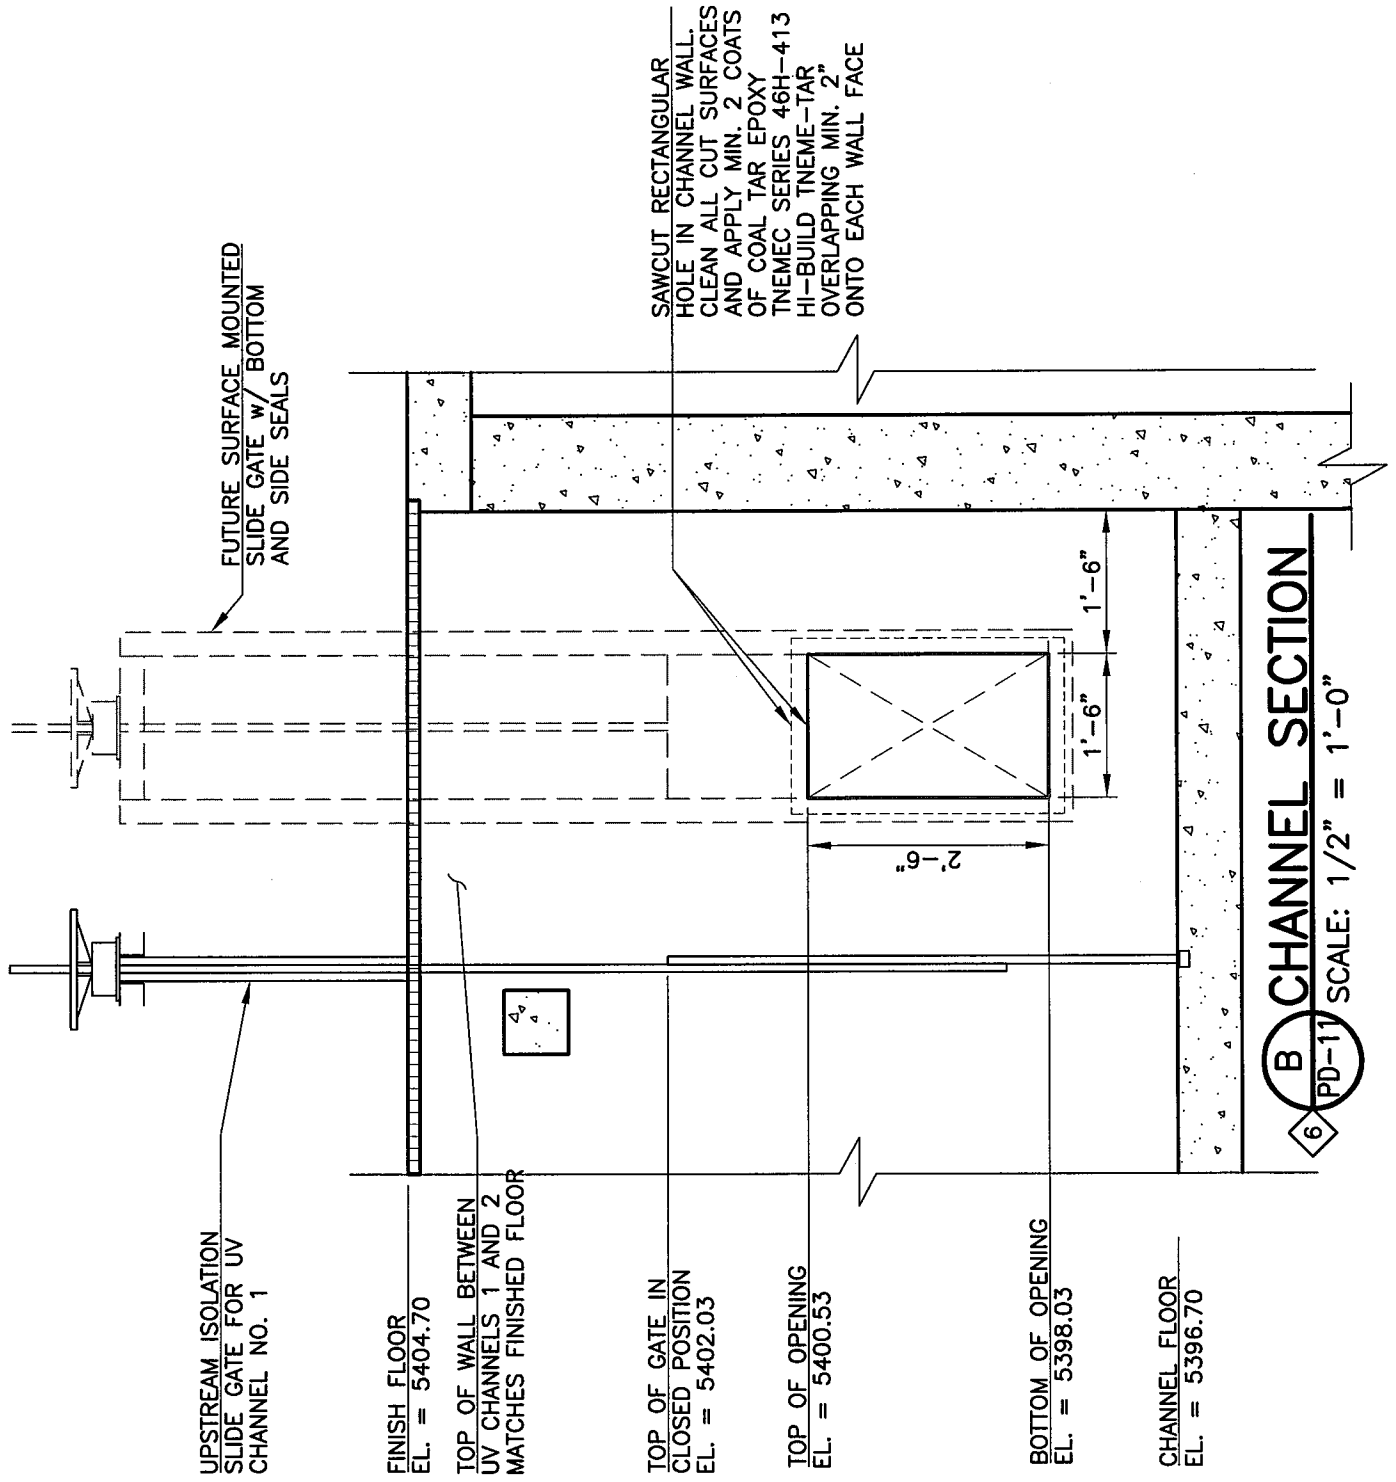

B CHANNEL SECTION
 PD-11 SCALE: 1/2" = 1'-0"