



Weaver

CONSTRUCTION MANAGEMENT

3679 S Huron Street, Suite 404 Englewood, Colorado 80110

Phone: (303) 789-4111 FAX: (303) 789-4310

SUBMITTAL TRANSMITTAL

July 5, 2012

Submittal No: 03200-019

PROJECT: **Harold Thompson Regional WRF**
Birdsall Rd.
Fountain, CO 80817
Job No. 2908

ENGINEER: **GMS, Inc.**
611 No. Weber St., #300
Colorado Springs, CO 80903
719-475-2935 Roger Sams

OWNER: **Lower Fountain Metropolitan
Sewage Disposal District**
901 S. Santa Fe Ave.
Fountain, CO 80817
719-382-5303 James Heckman

CONTRACTOR: **Dalco Industries Inc.**
3730 Salem Street
Denver, CO 80239
303-371-3950 David Tarin

SUBJECT: Foundation Plan @ Operations Building (OP-2)

SPEC SECTION: 03200 - Concrete Reinforcement


PREVIOUS SUBMISSION DATES:

DEVIATIONS FROM SPEC: ___ YES X NO

CONTRACTOR'S STAMP: This submittal has been reviewed by Weaver Construction Management and, unless indicated otherwise, has been found to be in conformance with the intent of the contract documents.

<p>Contractor's Stamp:</p> <p>Date: 7/5/12</p> <p>Reviewed by: Jeff Burst</p> <p>(X) Reviewed Without Comments () Reviewed With Comments</p>	<p>Engineer's Stamp:</p>
---	--------------------------

ENGINEER'S COMMENTS: _____

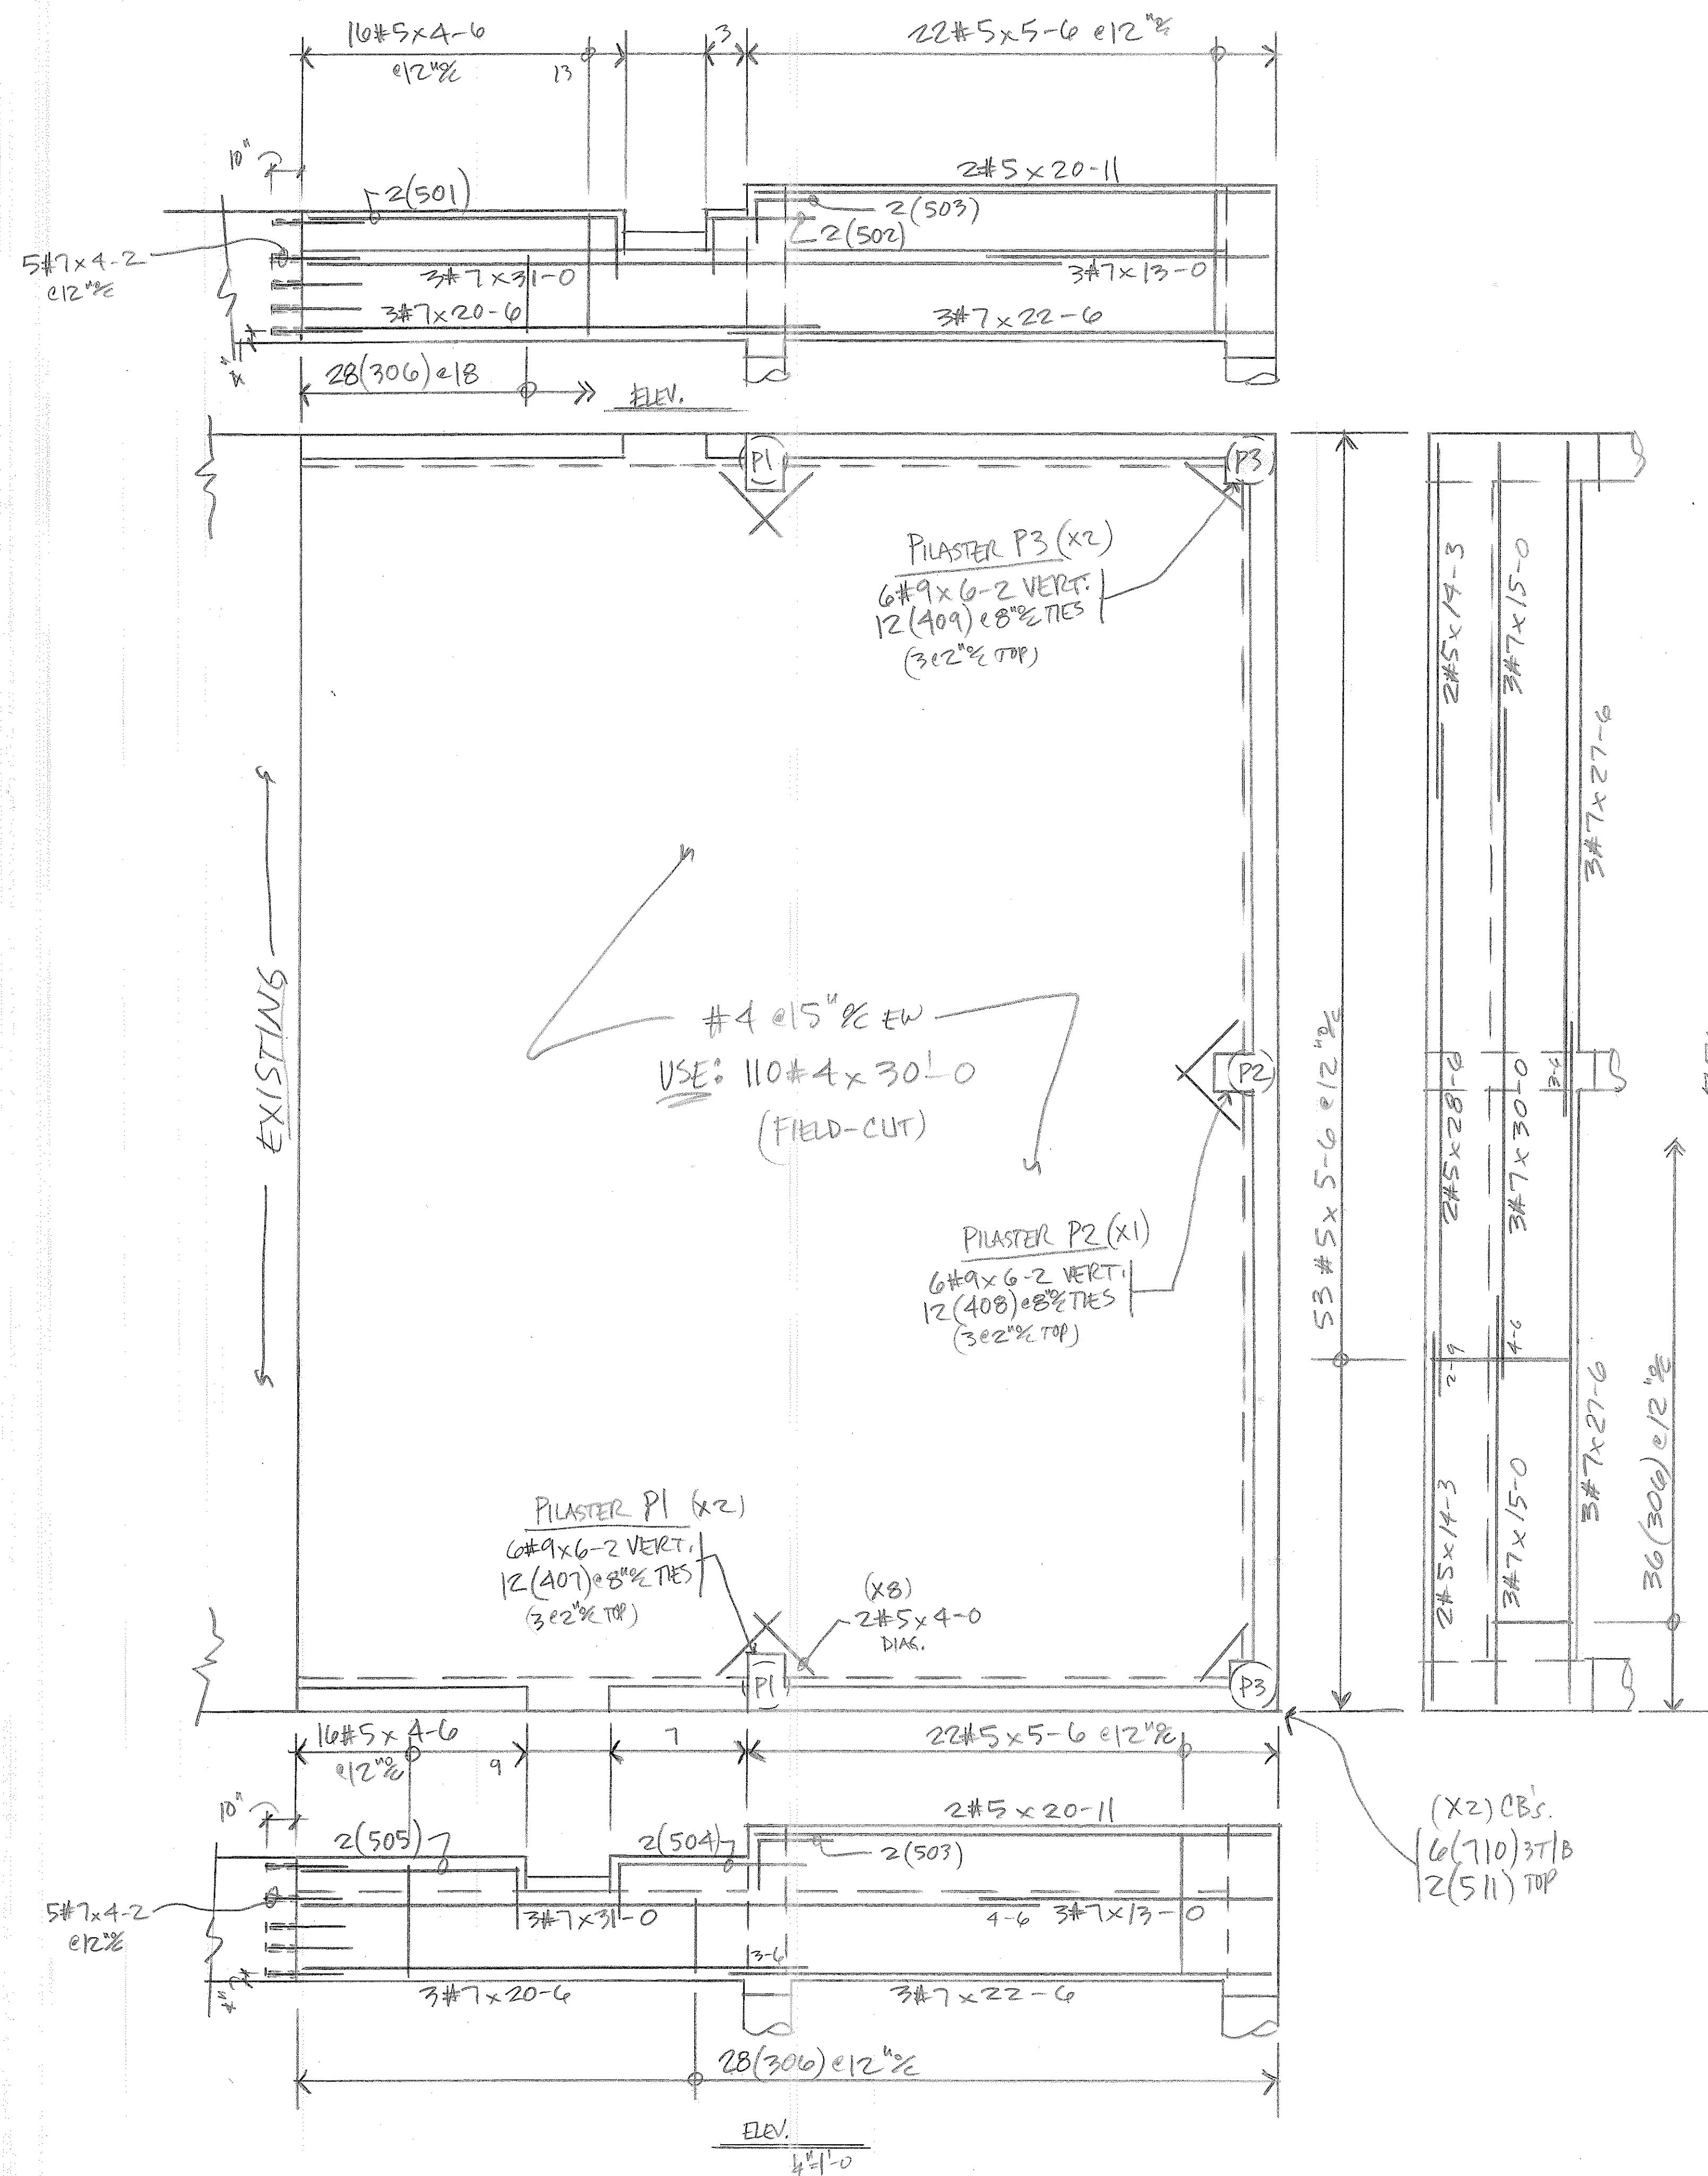

2-0	12-6	2-0	4-3	2-0	3-0	2-0	8-3	2-0	8-6	3-1	1-1
501		502		503		504		505		306	
2-1	1-3	2-4	1-3	1-9	1-9	4-6	4-6	2-9	2-9		
407		408		409		710		511			

NO	DATE	ISSUED FOR
AREA CODE 303 371-3950 3730 SALEM ST. DENVER, CO. 80239		
JOB HDTWWTP OPERATION BLDG		
LOCATION FOUNTAIN, CO.		
DESCRIPTION FOUND. PLAN		
CONTRACTOR WEAVER CONST.		
ARCHITECT GMS, INC		
DRAWN: DJARIN	CHECKED:	DATE: 7/4/12
REVISIONS:	JOB NO. 10032	DRAWING NO. OP-2

- (TOP) LAP (OTHERS)
- 1-7-#3-1-2
 - 2-1-4-1-7
 - 2-7-5-2-0
 - 3-1-6-2-5
 - 4-5-7-3-5
 - 5-1-8-3-11
 - 5-9-9-4-5

FOUND. PLAN
4"=1'-0"

SEC. e DOOR